

SCALE VERIFICATION
 THE BAR BELOW IS 1" ON THE ORIGINAL DRAWING. IF THIS DRAWING SCALES OTHERWISE, ADJUST THE SCALE ACCORDINGLY.

Schaaf & Wheeler
 CONSULTING CIVIL ENGINEERS
 1171 HOMESTEAD ROAD, STE 255
 SANTA CLARA, CA 95050
 (408) 246-4848



CONFORMED PLAN SET

DATE: 4/15/2022
 SCALE: AS SHOWN
 DRAWN BY: VCB
 DRAWING NAME: CHRYSLER PS
 DESIGNED BY: FTS
 CHECKED BY: CDA
 SURVEYED BY:

APPROVED:
 TANSIHA WERNER, P.E., CITY ENGINEER
 CITY OF MENLO PARK
 DATE: 7/29/23
 R.C.E. #

NO.	BY	DATE	REVISIONS
▲			
▲			
▲			
▲	BFC	7/31/2023	CONSTRUCTION DESIGN CHANGE 1 - STRUCTURE SHIFT
▲	VB	6/5/2023	CONFORMED PLANSET




CITY OF MENLO PARK
PUBLIC WORKS DEPARTMENT
 701 LAUREL STREET, MENLO PARK, CA 94025-3483
 PHONE (650) 330-6740 FAX (650) 327-5497

CHRYSLER STORMWATER PUMP STATION IMPROVEMENTS
PUMP STATION SITE PLAN

SHEET
C12

12 OF 80

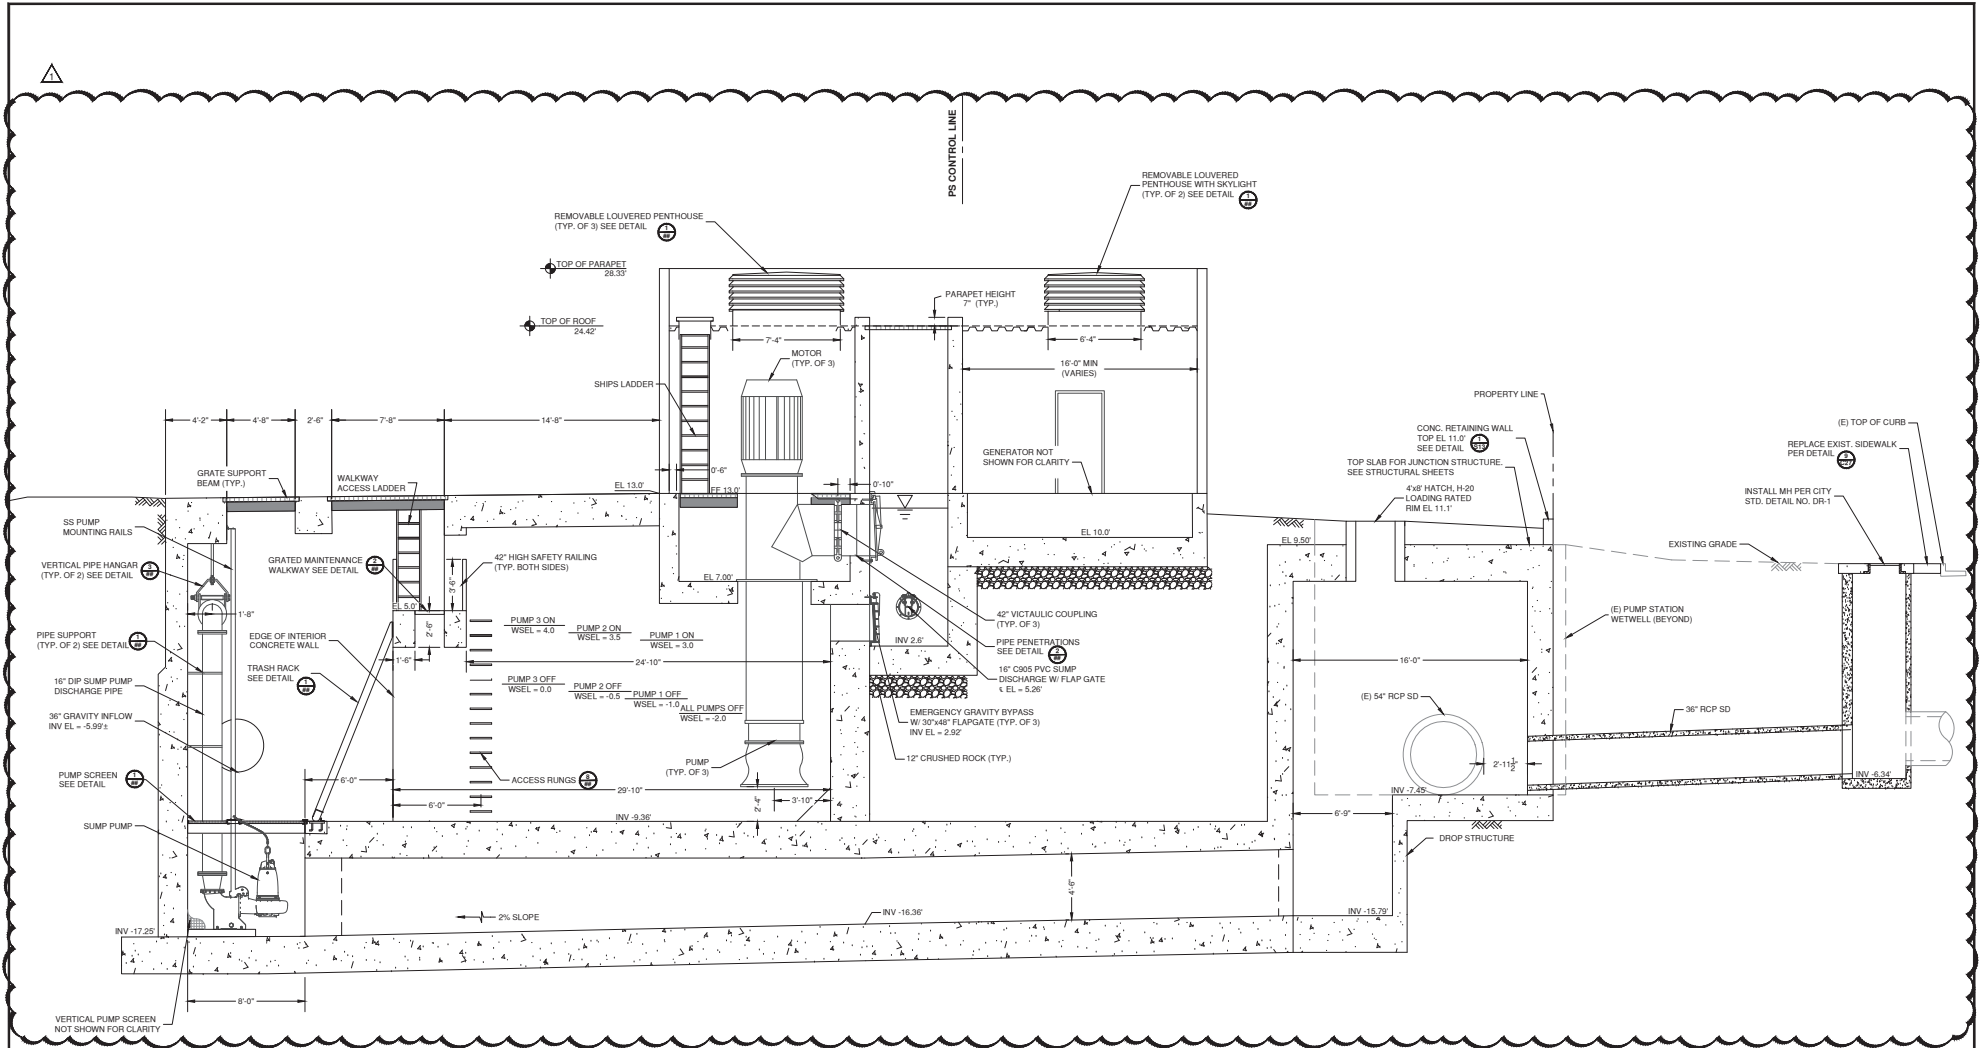

NOTE:
 1. TIE-OFF FALL PROTECTION CABLE SHALL BE 1/2" TYPE 316 SS. MOUNT TO CONCRETE PARAPET USING 2" STAINLESS STEEL EYEBOLTS WITH 2-3/4" EMBEDMENT AND ADHESIVE ANCHORING SYSTEM.

SECTION C
 1/4" = 1'-0"

SCALE VERIFICATION
 THE BAR BELOW IS 1" ON THE ORIGINAL DRAWING. IF THIS DRAWING SCALES OTHERWISE, ADJUST THE SCALE ACCORDINGLY.

Schaaf & Wheeler
 CONSULTING CIVIL ENGINEERS
 1171 HOMESTEAD ROAD, STE 255
 SANTA CLARA, CA 95050
 (408) 246-4848



CONFORMED PLAN SET

DATE: 4/15/2022
 SCALE: AS SHOWN
 DRAWN BY: VCB
 DRAWING NAME: CHRYSLER PS
 DESIGNED BY: FIS
 CHECKED BY: CDA
 SURVEYED BY:

APPROVED:
 TANSHA WERNER, P.E., CITY ENGINEER
 CITY OF MENLO PARK
 DATE: 7/28/23
 R.C.E. #

NO.	BY	DATE	REVISIONS
1	BFC	7/31/2023	CONSTRUCTION DESIGN CHANGE 1 - STRUCTURE SHIFT
2	VB	8/5/2023	CONFORMED PLANSET




CITY OF MENLO PARK
 PUBLIC WORKS DEPARTMENT
 701 LAUREL STREET, MENLO PARK, CA 94025-3483
 PHONE (650) 330-6740 FAX (650) 327-5497


CHRYSLER STORMWATER PUMP STATION IMPROVEMENTS
 PUMP STATION SECTIONS - C

SHEET
 C18


18 OF 80

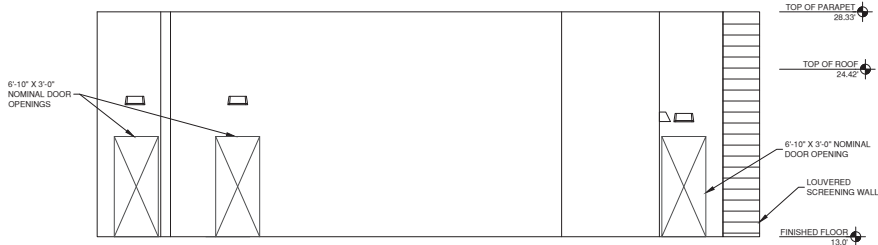


WEST ELEVATION
1/4" = 1'-0"

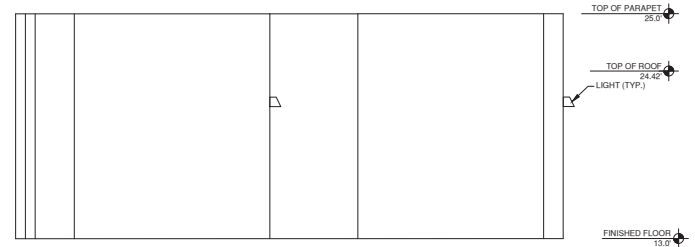

NORTH ELEVATION
1/4" = 1'-0"

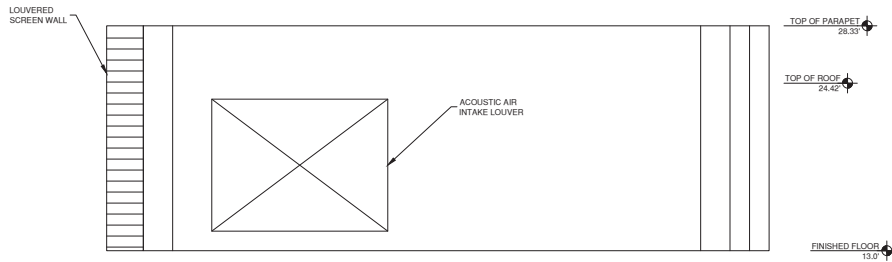

EAST ELEVATION
1/4" = 1'-0"

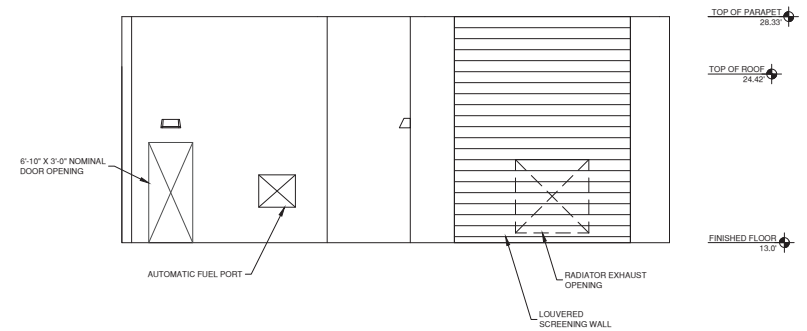

SOUTH ELEVATION
1/4" = 1'-0"

SCALE VERIFICATION

THE BAR BELOW IS 1" ON THE ORIGINAL DRAWING. IF THIS DRAWING SCALES OTHERWISE, ADJUST THE SCALE ACCORDINGLY.



CONFORMED PLAN SET

Schaaf & Wheeler
CONSULTING CIVIL ENGINEERS
1171 HOMESTEAD ROAD, STE 255
SANTA CLARA, CA 95050
(408) 246-4848



DATE: 4/15/2022
SCALE: AS SHOWN
DRAWN BY: VCB
DRAWING NAME: CHRYSLER PPS
DESIGNED BY: FTS
CHECKED BY: CDA
SURVEYED BY:

APPROVED:
TANISHA WERNER, P.E., CITY ENGINEER
CITY OF MENLO PARK
DATE: 7/8/2022
R.C.E. #

NO.	BY	DATE	REVISIONS
1	VB	6/5/2023	CONFORMED PLANSET



CITY OF MENLO PARK
PUBLIC WORKS DEPARTMENT
701 LAUREL STREET, MENLO PARK, CA 94025-3483
PHONE (650) 330-6740 FAX (650) 327-5497

CHRYSLER STORMWATER PUMP STATION IMPROVEMENTS
PUMP STATION ELEVATIONS

SHEET
C25

25 OF 80